


MAPEPROOF AL AP & IDROCRETE KR 1000 WATERTIGHT CONCRETE MAIN SECTION

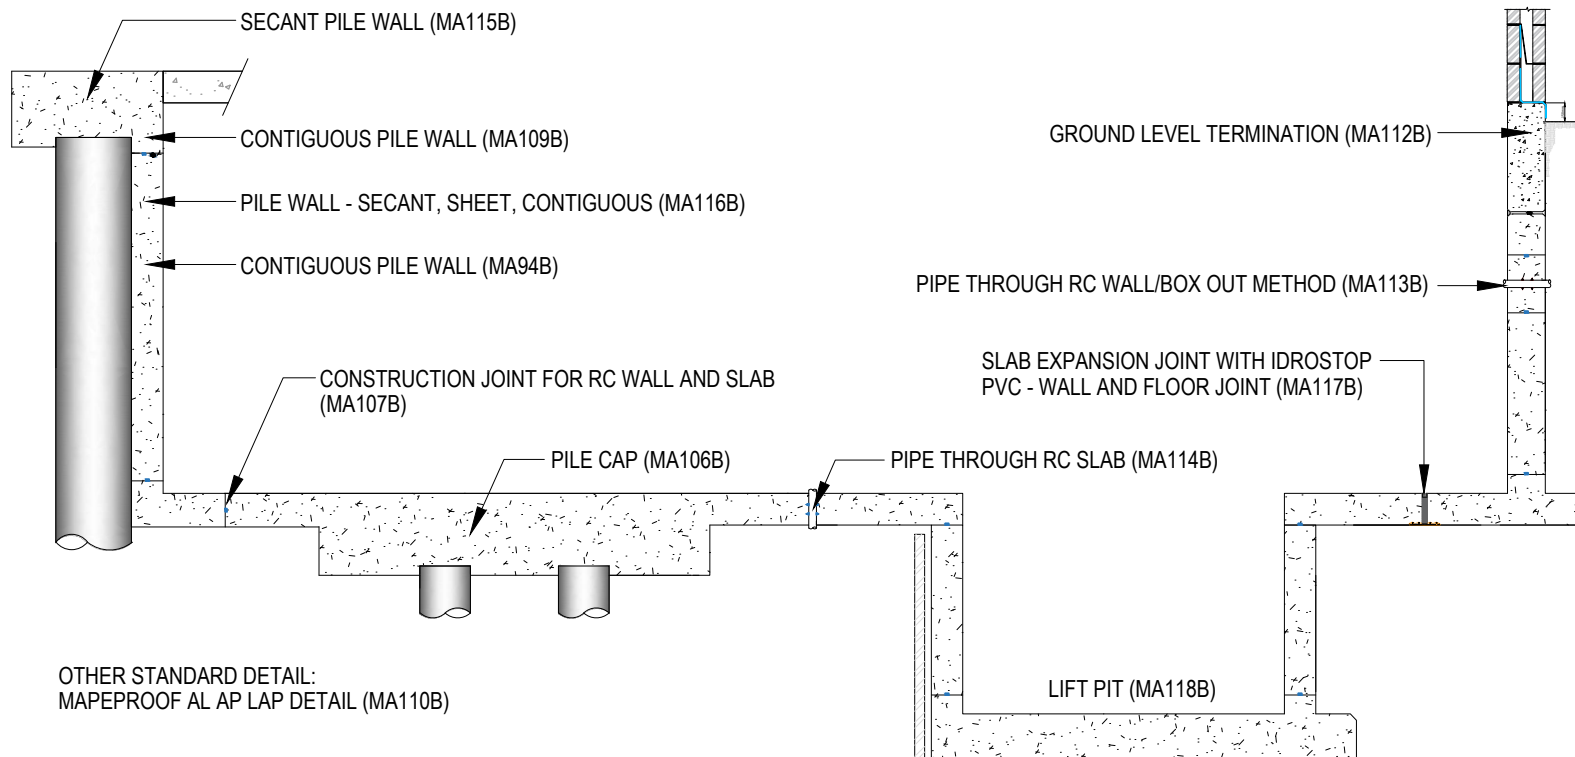

OTHER STANDARD DETAIL:
MAPEPROOF AL AP LAP DETAIL (MA110B)

Drawing Details:

STATUS: APPROVED

Drawing Title:
MAPEPROOF AL AP & IDROCRETE
KR 1000 WATERTIGHT CONCRETE-
MAIN SECTION

Drawing Ref: MA111B

Date: 02/10/2023

Drawn by: DB

Checked by: LR

Approved by: ADL



Mapei House, Steel Park Road,
Halesowen, B62 8HD
Website: www.mapei.co.uk,
Email: technical-uk@mapei.co.uk